


EMPLOYEE ONLY EMPLOYEE ONLY

ROLL UP DOOR

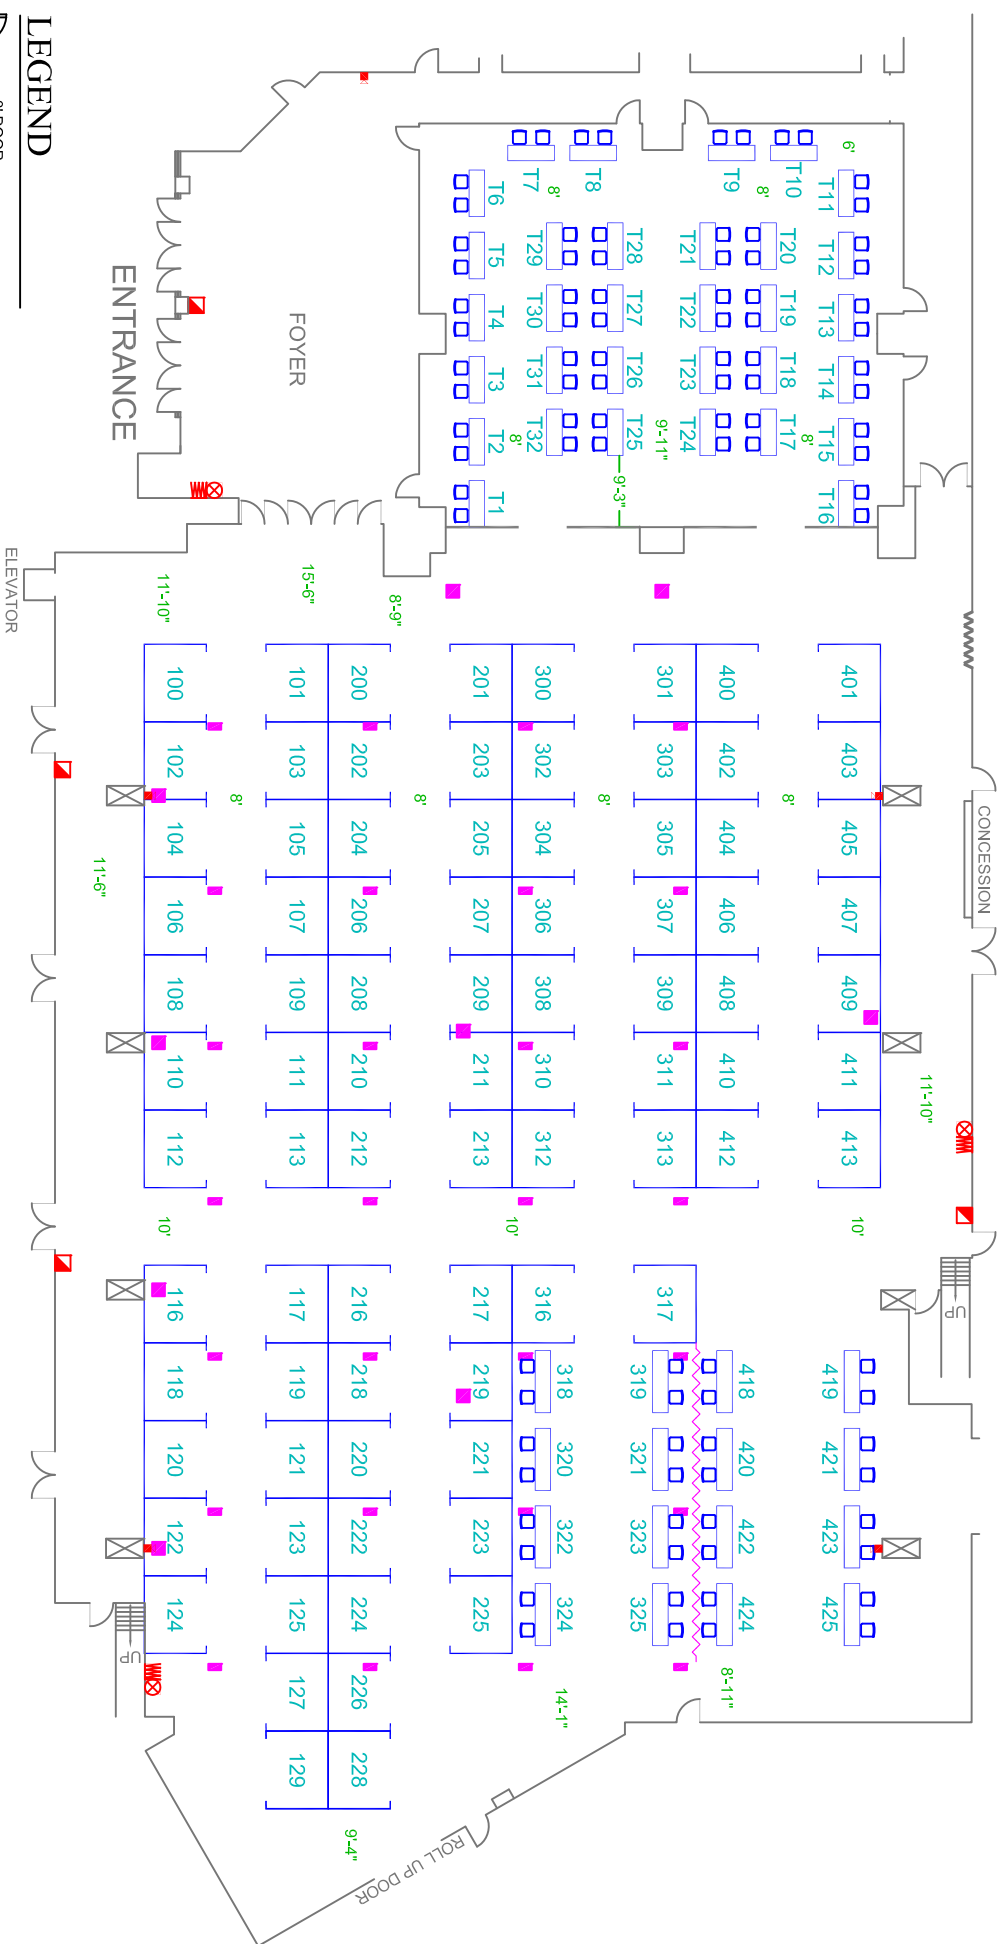

### LEGEND

- 3' DOOR (UNLESS NOTED)
- 6' DOUBLE DOOR (UNLESS NOTED)
- FIRE ALARM PULL
- FIRE HOSE & VALVE CABINET
- FIRE STROBE & HORN (106" FROM FLOOR TO BOTTOM)
- FLOOR PORT
- DRAPE

SHOW INFO:

# AMAZING ARIZONA COMIC CON 2012

JANUARY 6 - 8, 2012

MESA CONVENTION CENTER - MAIN HALL

MESA, ARIZONA

REPRESENTATIVE: MARK FARMER JOB NO. S150112 DRAWN BY JS SHEET 1 OF 1

 
SPECIFICATIONS

- 82 - 8' X 10' BOOTHS
- 32 - 6' TABLE TOPS / 2 SEATS
- 16 - 8' TABLE TOPS / 2 SEATS
- DRAPE - 41' L.F.

VER#

DATE

VER#	DATE
1	12/14/11
2	12/21/11
-	-/-/-
-	-/-/-
-	-/-/-



Expositions ... Trade Shows ... Conferences  
 2001 South 15th Avenue Phoenix, AZ 85007  
 (602) 923-0011 ... (602) 923-0044 (Fax)

800.471.7330... (602) 923-0011... (602) 923-0044 (Fax)

CONFERENCES, TRADE SHOWS, CONFERENCES, ALL RIGHTS RESERVED. NO PART OF THIS PUBLICATION MAY BE REPRODUCED, STORED IN A RETRIEVAL SYSTEM, OR TRANSMITTED IN ANY FORM OR BY ANY MEANS, ELECTRONIC, MECHANICAL, PHOTOCOPYING, RECORDING, OR OTHERWISE, WITHOUT THE EXPRESS WRITTEN PERMISSION OF GSI ETC. EXPOSITIONS... TRADE SHOWS... CONFERENCES.

ENERGY SECTOR HAS BEEN MADE TO ENSURE THE ACCURACY OF ALL INFORMATION CONTAINED ON THE FLOOR PLAN. HOWEVER, NO WARRANTIES, EITHER EXPRESSED OR IMPLIED, ARE MADE WITH RESPECT TO THE ACCURACY OF THE INFORMATION. THE ARCHITECT, ENGINEER, CONTRACTOR, AND OTHER ARCHITECTURAL COMPONENTS OF THE PLAN SHALL BE RESPONSIBLE FOR THE ACCURACY OF THE INFORMATION. THE ARCHITECT, ENGINEER, CONTRACTOR, AND OTHER ARCHITECTURAL COMPONENTS OF THE PLAN SHALL BE RESPONSIBLE FOR THE ACCURACY OF THE INFORMATION. THE ARCHITECT, ENGINEER, CONTRACTOR, AND OTHER ARCHITECTURAL COMPONENTS OF THE PLAN SHALL BE RESPONSIBLE FOR THE ACCURACY OF THE INFORMATION.

